



FIRST FLOOR ELECTRICAL PLAN

SCALE: 1/4" = 1'-0"

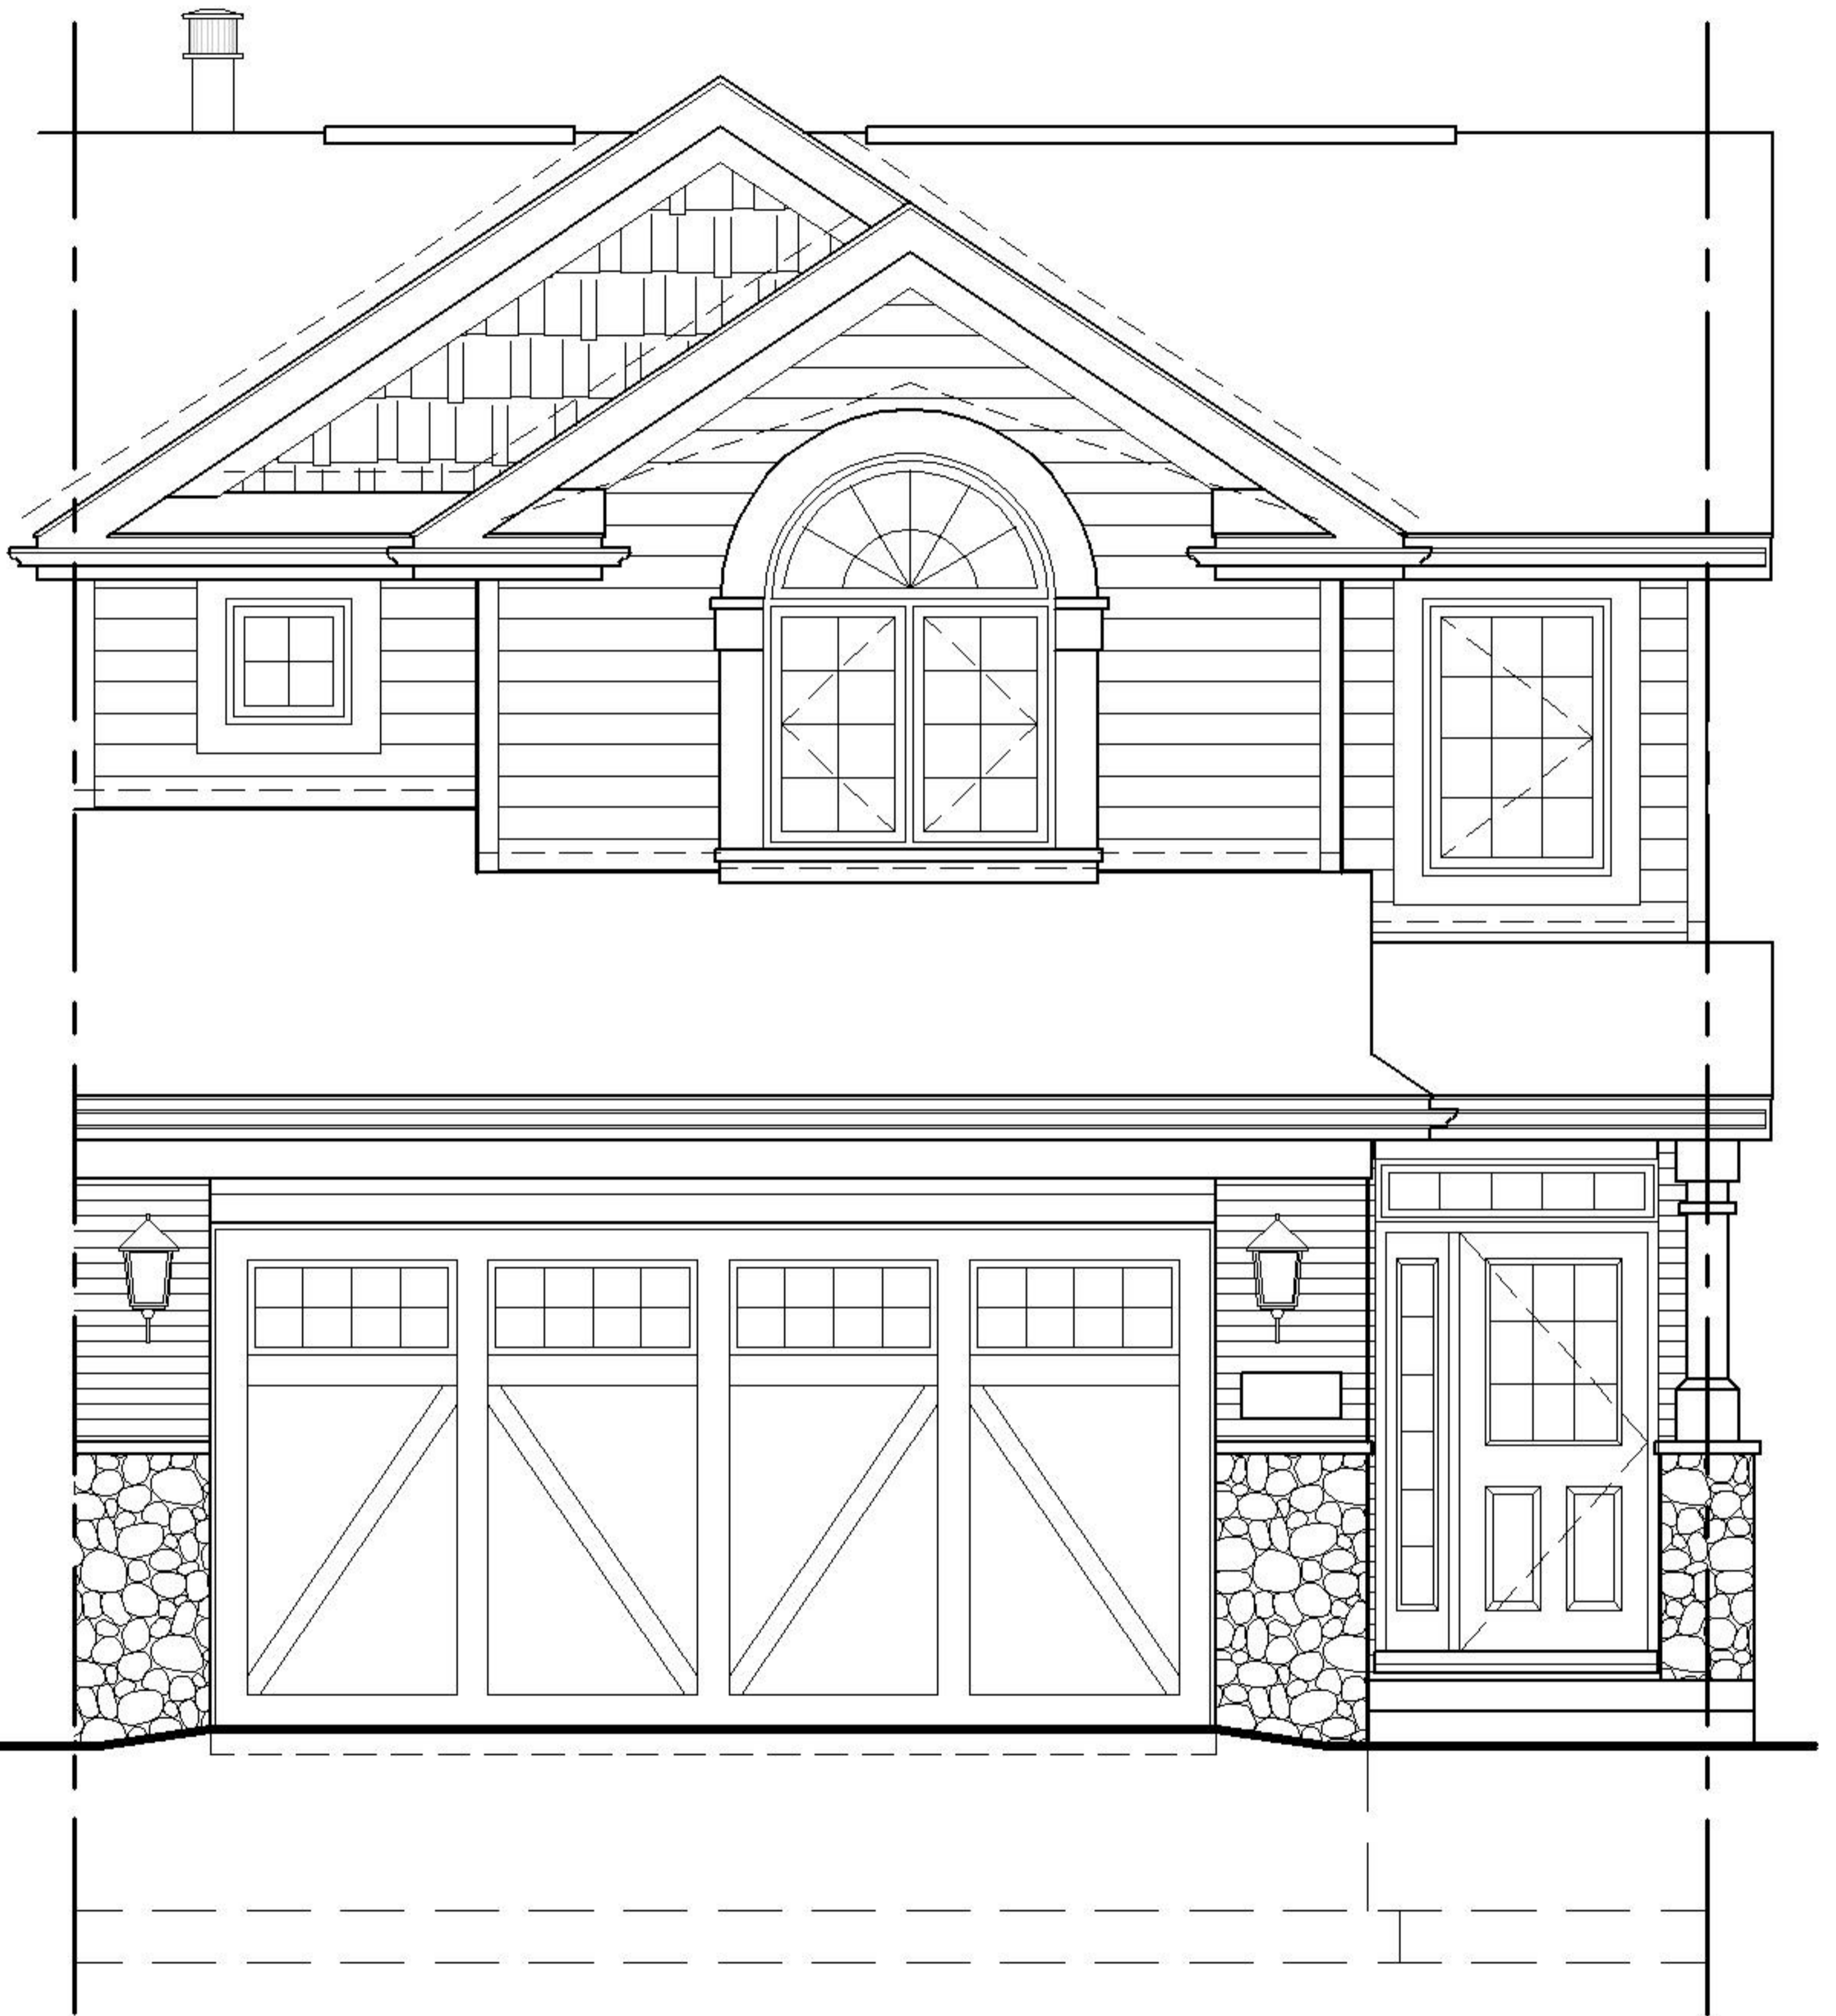

FRONT ELEVATION

SCALE: 1/4" = 1'-0"

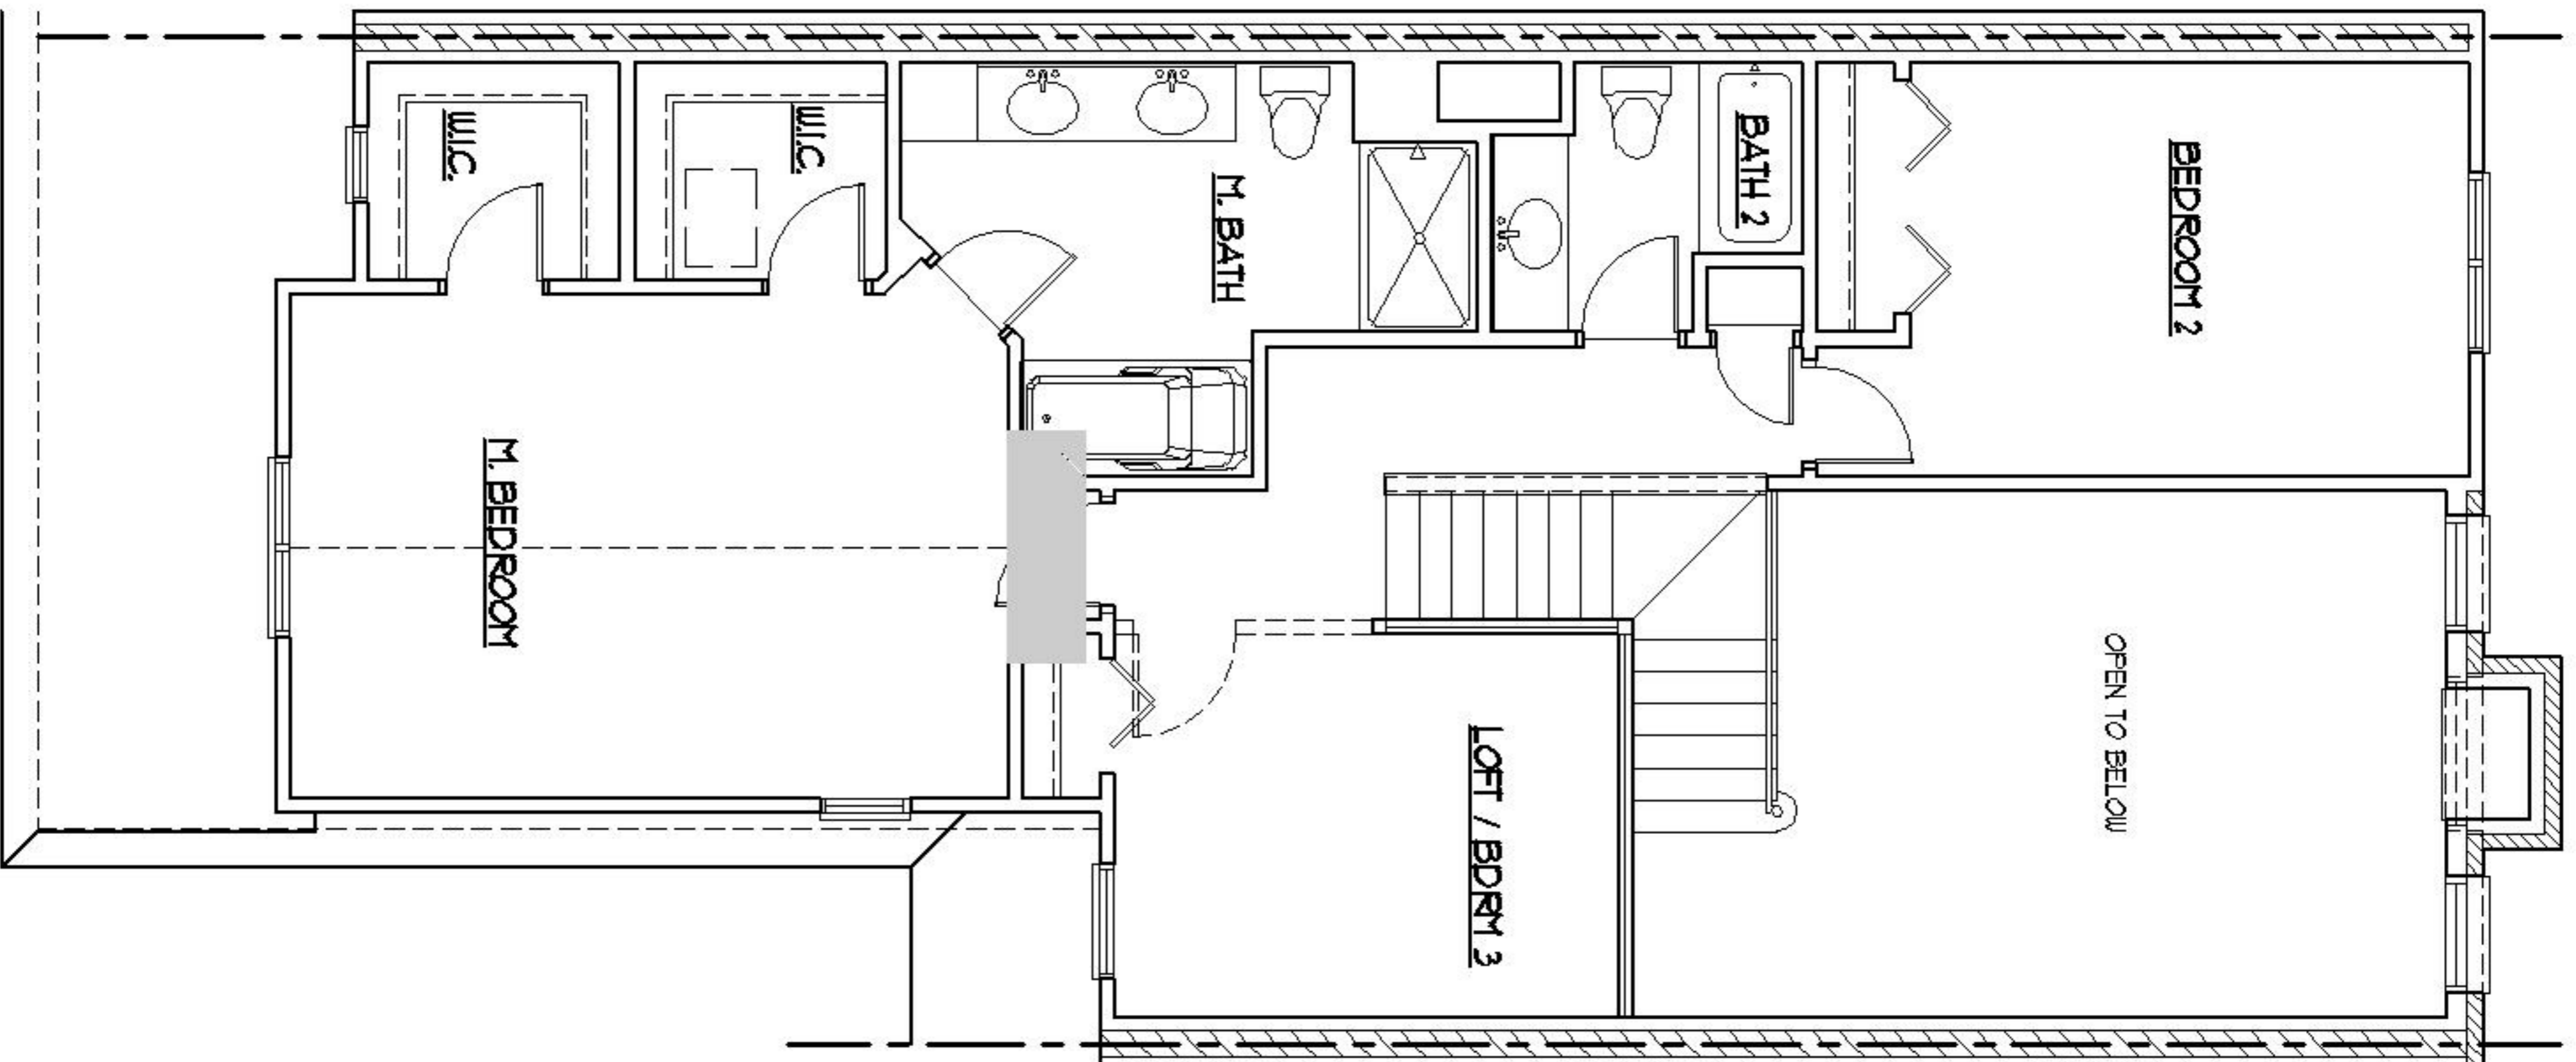

SECOND FLOOR ELECTRICAL PLAN

SCALE: 1/4" = 1'-0"